

FINISH SCHEDULE					
ROOM NAME	FLOOR	BASE	WALL	CEILING	01-11-19
(100) DINING ROOM	T200 24" X 24" TILE	T111 6" X 36" TILE	P101, P104 T111 W102 PAINT TILE WALL COVERING	C1 2' X 2' ARMSTRONG, SEPIA #PNB1311 C3 GYP BOARD W/ PAINT P103	
(101) SERVING AREA	S1 S2 PLAIN ABRASIVE IN HIGH TRAFFIC AREAS	S1 6" H CONT. (KITCHEN EQUIPMENT ON 6" NSF APPROVED LEGS)	T111 TILE	C3 GYP BOARD W/ SMOOTH WASHABLE PAINT	
(102) DRIVE-THRU STATION	S1 S2 PLAIN ABRASIVE IN HIGH TRAFFIC AREAS	S1 6" H CONT. (KITCHEN EQUIPMENT ON 6" NSF APPROVED LEGS)	WP1 FRP PANEL	C2 2' X 4' SUSPENDED GRID WASHABLE VINYL COATED GYP BOARD PANELS	
(103) KITCHEN	S1 S2 PLAIN ABRASIVE IN HIGH TRAFFIC AREAS	S1 6" H CONT. (KITCHEN EQUIPMENT ON 6" NSF APPROVED LEGS)	WP3 S.S. BEHIND COOK LINE WP1 FRP PANEL	C2 2' X 4' SUSPENDED GRID WASHABLE VINYL COATED GYP BOARD PANELS	
(104) KITCHEN PREP.	S1 S2 PLAIN ABRASIVE IN HIGH TRAFFIC AREAS	S1 6" H CONT. (KITCHEN EQUIPMENT ON 6" NSF APPROVED LEGS)	WP1 FRP PANEL	C2 2' X 4' SUSPENDED GRID WASHABLE VINYL COATED GYP BOARD PANELS	
(105) WALK-IN COOLER	S1 S2 PLAIN ABRASIVE IN HIGH TRAFFIC AREAS	S.S. / ALUMINUM WITH 3/8" RADIUS	EXT S.S.	ALUMINUM GALVANIZED STAINLESS STEEL	
(105A) WALK-IN FREEZER	GALVANIZED STAINLESS STEEL S1 SILKAL UNDER WIF SUBFLOOR	S.S. / ALUMINUM WITH 3/8" RADIUS	INT S.S.	ALUMINUM GALVANIZED STAINLESS STEEL	
(106) MEN'S ROOM	T200 24" X 24" TILE	SCHLUTER	T108 TILE	C3 GYP BOARD W/ P101 SMOOTH WASHABLE PAINT	
(107) WOMEN'S ROOM	T200 24" X 24" TILE	SCHLUTER	T108 TILE	C3 GYP BOARD W/ P101 SMOOTH WASHABLE PAINT	
(108) VESTIBULE	T200 24" X 24" TILE	T111 6" X 36" TILE	P104 PAINT GYP BOARD T111 TILE	C3 GYP BOARD W/ P101 SMOOTH WASHABLE PAINT	
(109) NOT USED	-	-	-	-	
(110) EXTERIOR STORAGE	SEALED CONCRETE, SMOOTH FINISH	-	WP1 FRP PANEL	C3 GYP BOARD W/ P101 SMOOTH WASHABLE PAINT	

DOOR & HARDWARE SCHEDULE													
INSTALLED AND FURNISHED BY: G.C. UNLESS NOTED OTHERWISE													
CONTRACTOR TO PURCHASE DOOR HARDWARE & FRAME DIRECTLY FROM PANDA'S NATIONAL ACCOUNT SUPPLIER. SUPPLIER TO PROVIDE ALL STOREFRONT DOOR HARDWARE, PLAM DOORS & FRAMES AND HM DOORS & FRAMES													
CONTACT FOR QUOTING, ORDERING & LOGISTICS APRIL WALDREN, PROJECT MANAGER 800-887-4307 EXT. 350 PHONE AprilW@locknet.com panda@locknet.com													
CONTACT FOR GENERAL ACCOUNT NEEDS ANGIE HAINES, ACCOUNT MANAGER 800-887-4307 EXT. 145 PHONE / 859-509-4031 MOBILE AngieH@locknet.com, panda@locknet.com													
ADDITIONAL CONTACTS: TUPAC DOWNS, SALES MANAGER, 800-887-4307 EXT. 146 EDDIE ANDUEZA, DIR. ARCH. DOOR & HARDWARE SOL., eddie@locknet.com, 859-432-2289													
NO.	DOOR MATERIAL	SIZE	FRAME	FACEDGE	THK.	CORE	LITE	RATE	LOCKSET	HARDWARE	HINGE	STOP	REMARKS
(01)	ALUMINUM STOREFRONT	3'-0" X 7'-0"	ALUM.	DARK BRONZE ANODIZED ALUM.	1 1/2"	HOLLOW GLASS	-	-	•	•	•	•	• PROVIDE PULL ON EXTERIOR SIDE
(02)	ALUMINUM STOREFRONT	3'-6" X 7'-0"	ALUM.	DARK BRONZE ANODIZED ALUM.	1 1/2"	HOLLOW GLASS	-	-	•	•	•	•	• PROVIDE PULL ON EXTERIOR SIDE
(03)	S.C. WOOD	3'-0" X 7'-0"	H. MTL.	PLASTIC LAMINATE PRE-FINISHED	1 1/2"	SOLID	-	-	•	•	•	•	• KICKPLATE ON EACH SIDE OF DOOR
(04)	NOT USED	-	-	-	-	-	-	-	•	•	•	•	•
(05)	HOLLOW METAL	3'-6" X 7'-0"	H. MTL.	PAINTED	1 1/2"	INSUL.	-	-	•	•	•	•	• KICKPLATE ON INT. SIDE OF DOOR
(06)	HOLLOW METAL	(2) 3'-0" X 7'-0"	H. MTL.	PAINTED	1 1/2"	INSUL.	-	-	•	•	•	•	•
(07)	HOLLOW METAL	3'-0" X 7'-0"	H. MTL.	PAINTED	1 1/2"	INSUL.	-	-	•	•	•	•	• WITH LOUVERED WENT AIR-GUARD SCREEN
(08)	ALUMINUM STOREFRONT	3'-0" X 7'-0"	ALUM.	DARK BRONZE ANODIZED ALUM.	1 1/2"	HOLLOW GLASS	-	-	•	•	•	•	• ONE-WAY TINTING FILM ON INTERIOR SIDE

 
WALL SCHEDULE		INSTALLED AND FURNISHED BY: G.C. UNLESS NOTED OTHERWISE	
NO.	DESCRIPTION		
(1)	3'-6" 20GA. METAL STUD WALL W/ 1/2" TYPE "X" GYP. BOARD BOTH SIDES (SEE ARCHITECTURAL DETAILS & ELEVATIONS)		
(2)	3'-6" 20GA. METAL STUD WALL W/ 1/2" TYPE "X" GYP. BOARD ON ONE SIDE (SEE ARCHITECTURAL DETAILS & ELEVATIONS)		
(3)	(2) 3'-6" 20GA. METAL STUD WALLS W/ 1/2" TYPE "X" GYP. BOARD BOTH SIDES (SEE ARCHITECTURAL DETAILS & ELEVATIONS)		
(4)	3'-6" 20GA. METAL STUD LOW WALL W/ 1/2" TYPE "X" GYP. BD BOTH SIDES. PROVIDE 3 1/2" KNEE-WALL BRACE/POST @ CORNERS AND @ 48" O.C.		
(5)	6" 20GA. METAL STUD WALL W/ 1/2" TYPE "X" GYP. BOARD BOTH SIDES (SEE ARCHITECTURAL DETAILS & ELEVATIONS)		
(6)	6" 20GA. METAL STUD WALL W/ 1/2" TYPE "X" GYP. BOARD ONE SIDE (SEE ARCHITECTURAL DETAILS & ELEVATIONS)		
(7)	6" 20GA. METAL STUD LOW WALL W/ 1/2" TYPE "X" GYP. BOARD BOTH SIDES. PROVIDE 3 1/2" KNEE-WALL BRACE/POST @ CORNERS AND @ 48" O.C		
(8)	1 1/2" 20GA. HAT CHANNEL FURRING W/ 1/2" TYPE "X" GYP. BOARD ON ONE SIDE. REFER DETAILS FOR FURRING DISTANCE		


WALL PANEL SCHEDULE					INSTALLED AND FURNISHED BY: G.C. UNLESS NOTED OTHERWISE	
NO	MANUFACTURER	DESCRIPTION	MFG #	COLOR FINISH	REMARK	
(WP1)	CRANE COMPOSITES INC.	F.R.P. THICKNESS: .075	LBSCS.14	#636 (GRAY), SMISM	CONTACT: LINDA RUSE 310.857.9036	
(WP2)	-	S.S. PANEL (22 GA)	-	BRUSHED FINISH	FURNISHED BY PX, INSTALLED BY G.C.	
(WP3)	-	S.S. PANEL (22 GA)	-	DIAMOND PATTERN FINISH	FURNISHED BY PX, INSTALLED BY G.C.	
(WP4)	NOT USED					
(WP5)	NOT USED					
(WP10)	NOT USED					
(W102)	WOLF GORDON	RED BAMBOO	-	-	CONTACT: CATHY DY 310.770.1165 cathy.dy@wolfgordon.com	
(W103)	WOLF GORDON	CLOUD WALLCOVERING	-	-	CONTACT: CATHY DY 310.770.1165 cathy.dy@wolfgordon.com	


SPECIAL SURFACE SCHEDULE						INSTALLED AND FURNISHED BY: G.C. UNLESS NOTED OTHERWISE	
NO	MANUFACTURER	PRODUCT	MFG #	STAIN / COLOR	FINISH	REMARK	
(Q2-5)	NOT USED						
(Q2-6)	NOT USED						
(Q2-7)	CORIAN	ARTIFICIAL QUARTZ	-	LONDON SKY	POLISHED		
(Q2-8)	DALTILE	ARTIFICIAL QUARTZ	-	BROADWAY BLACK	POLISHED	SERVICE COUNTER & DRINK STATION PROVIDED BY PX, INSTALLED BY G.C.	


INTERIOR PAINT SCHEDULE						INSTALLED AND FURNISHED BY: G.C. UNLESS NOTED OTHERWISE	
NO	MANUFACTURER	MFG #	COLOR	FINISH	REMARK		
(P9A3)	SHERWIN-WILLIAMS	SW 7065	ARGOS	PROMAR 200, ZERO VOC, LATEX SEMI-GLOSS	REAR SERVICE DOOR		
(P9B)	NOT USED						
(P101)	SHERWIN-WILLIAMS	SW 6252	ICE CUBE	PROMAR 200, ZERO VOC, LATEX EGG-SHELL	RESTROOM & RESTROOM VESTIBULE CEILING, FRONT & UNDERSIDE OF SERVICE LINE SOFFIT/BULKHEAD AND DINING RM. SOFFIT		
(P102)	NOT USED						
(P103)	NOT USED						
(P104)	SHERWIN-WILLIAMS	SW 2850	CHELSEA GRAY	PROMAR 200, ZERO VOC, LATEX EGG-SHELL	DINING RM. WALLS, RESTROOM VESTIBULE WALLS		
(P105)	NOT USED						
(P106)	SHERWIN-WILLIAMS	SW 7020	BLACK FOX	DTM ACRYLIC GLOSS, LOW VOC	RESTROOM DOOR FRAMES & LCD NICHE (BACK WALL)		
(P205)	SHERWIN-WILLIAMS	SW 7675	SEALSKIN	PROMAR 200, ZERO VOC, LATEX EGG-SHELL	FRONT & BACK & UNDERSIDE FACES OF MENU BOARD		


### WALL LEGEND

 NEW EXTERIOR WALL

 NEW EXTERIOR WALL FRAMED WITH STRUCTURAL STEEL STUDS

 
 NEW INTERIOR WALL (FULL HT.)

 
 NEW INTERIOR WALL (LOW WALL - REF. ELEV. & DETAILS)

 
 WALK-IN BOX PANEL

 
NOTE: THE FOLLOWING STAINLESS STEEL PROVIDED BY PX-INSTALLED BY G.C.  
1. PANEL DIVIDERS AT WP3  
2. INSIDE CORNER AT WP3 TO WP2  
3. FLASHING AT TOP OF BASE WP3  
4. WP2 PIECE AT LENGTH OF WALL

NOTE: THE FOLLOWING STAINLESS STEEL PROVIDED BY G.C.-INSTALLED BY G.C.  
5. INSTALL 18 GA STAINLESS STEEL CORNER GUARD & WALL CAP INSIDE KITCHEN

 18 GA. STAINLESS STEEL CORNER GUARD - FULL HT.

 18 GA. STAINLESS STEEL CORNER GUARD - 4'-0" HIGH

 18 GA. STAINLESS STEEL CORNER GUARD/FRAME - ALL AROUND PERIMETER OF OPENING - FRAME TO BE WELDED WITH MITERED CORNERS TO FORM SINGLE UNIT.

 18 GA. STAINLESS STEEL WALL CAP

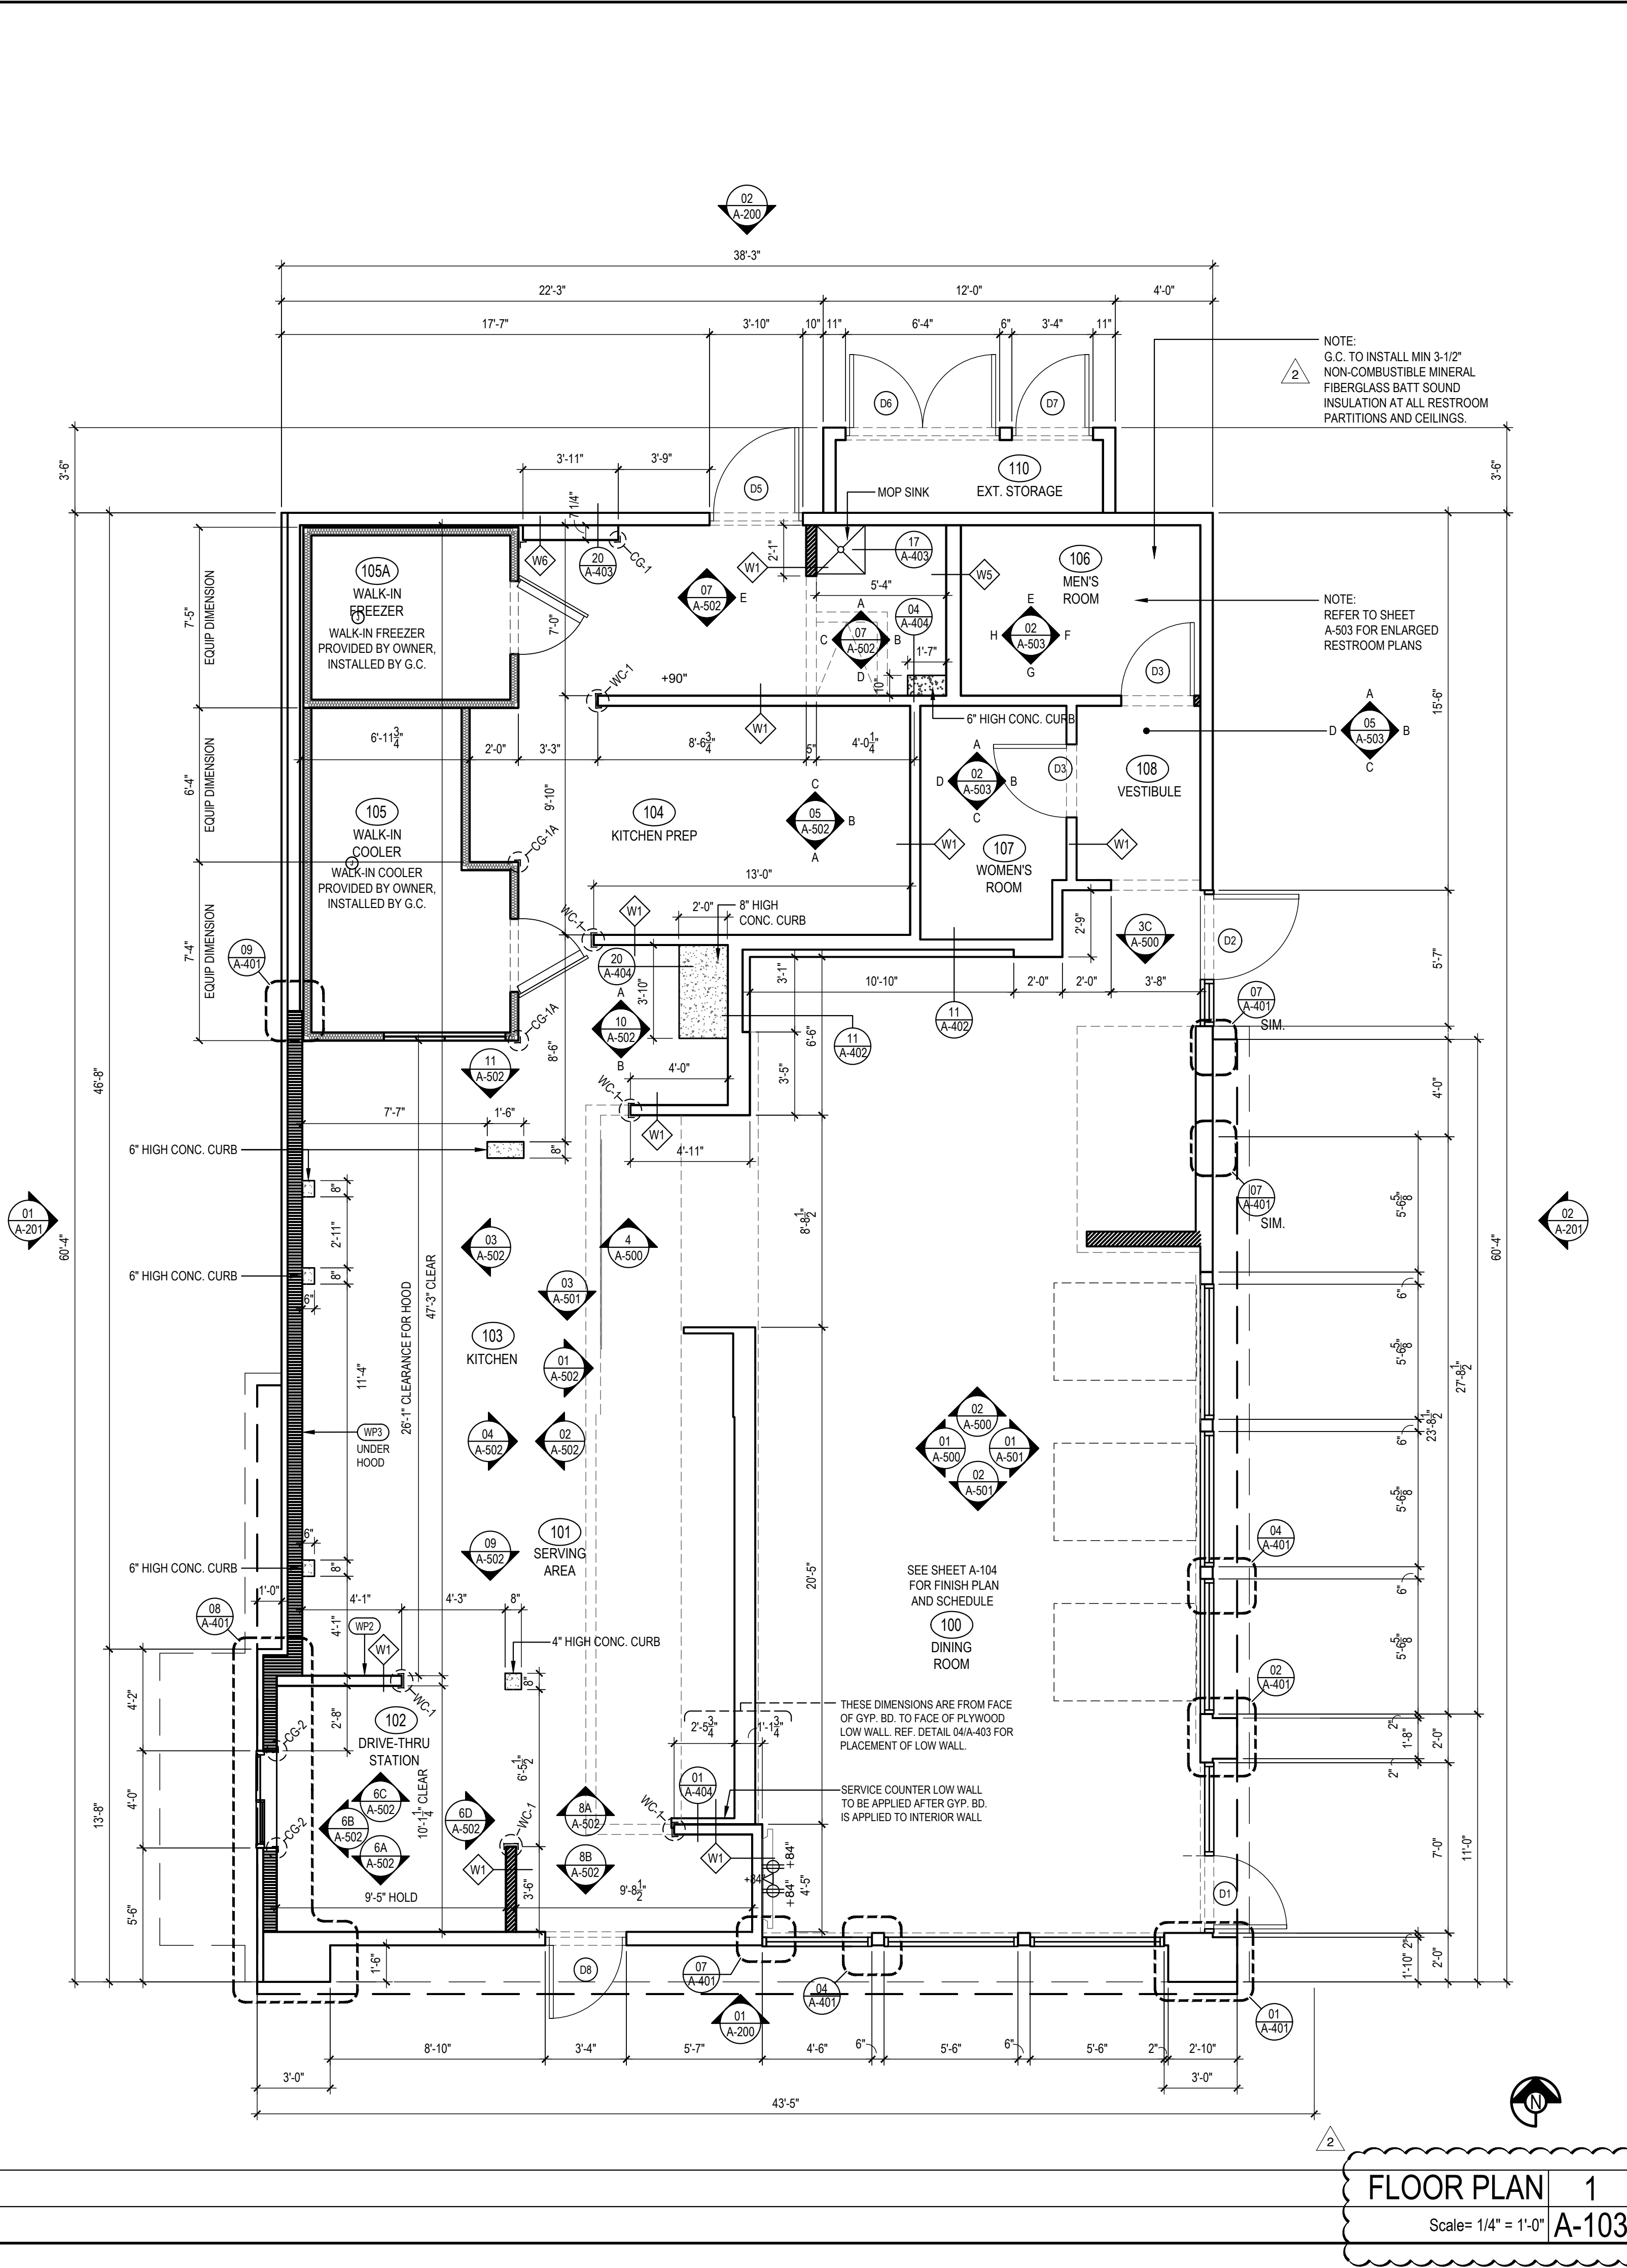
ALL OTHER STAINLESS STEEL BY G.C.

**NOTE!!!!!!!!!!!!!!:**

**\*ALL INTERIOR DIMENSIONS ARE TO FACE OF GYPSUM BOARD**

**NOTE:**

**CONTRACTOR TO NOTIFY 3rd PARTY VENDOR, PER THE VENDOR LIST, FOR WALL PRE-TREAT BEFORE CLOSING WALLS**



**FLOOR PLAN 1**  
Scale= 1/4" = 1'-0"



PANDA EXPRESS, INC.  
1683 Walnut Grove Ave.  
Rosemead, California  
91770  
Telephone: 626.799.9898  
Facsimile: 626.372.8288

All ideas, designs, arrangement and plans indicated or represented by this drawing are the property of Panda Express Inc. and were created for use on this specific project. None of these ideas, designs, arrangements or plans may be used by or disclosed to any person, firm, or corporation without the written permission of Panda Express Inc.

### REVISIONS:

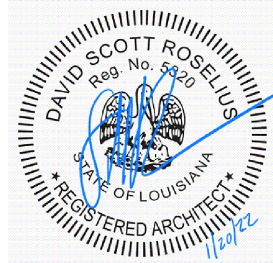
REV.	LDH COMMENTS	DATE
1	DRIVE THRU REVISION	01-14-2022

### ISSUE DATE:

PERMIT/BID ISSUE	09-20-2021
PERMIT/BID ISSUE	01-20-2022

### DRAWN BY:

PANDA PROJECT #: - S8-21-D8118  
PANDA STORE #: - D8118  
ARCH PROJECT #: - 20185



**Heights Venture**  
ARCHITECTURE • DESIGN

HOUSTON 1111 North Loop West, Suite 800 Houston, Texas 77008 713.869.1103 • DALLAS 5741 Legacy Drive, Suite 320 Plano, Texas 75024 972.490.7292 •

**PANDA EXPRESS**

TRUE WARM & WELCOME  
901 N. SERVICE RD. E.  
RUSTON, LA 71270

**A-103**

FLOOR PLAN

TRUE WARM & WELCOME 2200 R6  
© COPYRIGHT 2022 HEIGHTS VENTURE

PERMIT/BID SET